

Shepley Bulfinch Richardson & Abbott
Architecture / Planning / Interiors / Est. 1874
2 Seaport Lane, Boston, Massachusetts 02110
T: 617.423.1700 F: 617.451.2420
www.ShepleyBulfinch.com

Spiegel Zamecnik & Shah Inc.

54 Wall Street
New Haven, CT 06511
STRUCTURAL ENGINEER

Bard, Rao + Albanas

311 Arsenal Street
Watertown, MA 02472
M.E.P. ENGINEER

Tighe & Bond

1000 Bridgeport Avenue, Floor 3
Shelton, CT 06484
CIVIL ENGINEER

Towers | Golde

85 Willow Street
New Haven, CT 06511
LANDSCAPE ARCHITECT

R.W. Sullivan


529 Main Street, Suite 203
Boston, MA 02129
CODE & REGULATORY

NOTES:

1. REFER TO A801 FOR PARTITION TYPES AND DETAILS. WALL TYPES TO BE 1A3 STUD PARTITION U.N.O.
2. PARTITION TYPES AND DIMENSIONS INCLUDED ON "a" SERIES DETAIL. INTERIOR ELEVATION KEYS, WALL PROTECTION AND NOTES INCLUDED ON "b" SERIES PLAN DRAWINGS.
3. REFER TO A912 FOR BORROWED LIGHT, DOOR AND FRAME TYPES.
4. DOORS TO BE LOCATED WITH INSIDE FACE OF JAMB 6" FROM FACE OF ADJACENT WALL U.N.O.
5. DIMENSIONS ARE TO FINISH FACE OF G.W.B. U.N.O.
6. REFER TO INTERIOR ELEVATIONS AND TYPICAL MOUNTING HEIGHT SHEET FOR LOCATIONS OF PLUMBING FIXTURES.

- 1 HOUR FIRE SEPARATION ASSEMBLY
- 2 HOUR FIRE SEPARATION ASSEMBLY
- SMOKE BARRIER
- SMOKE PARTITION

NO.	DATE	DESCRIPTION	REVISION

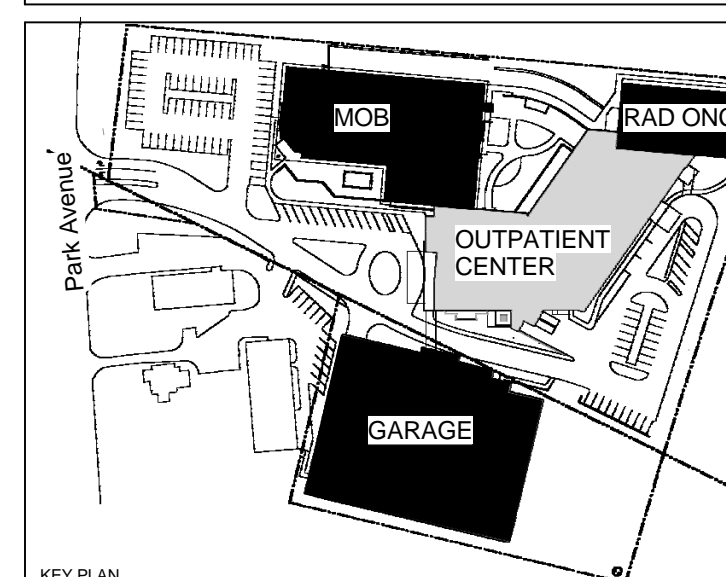

BRIDGEPORT HOSPITAL


OWNER

PARK AVENUE CAMPUS
OUTPATIENT CENTER

5520 Park Avenue
Trumbull, CT 06611

LEVEL 1 PLAN - DIMS AND
PARTITION TYPES

DRAWING TITLE

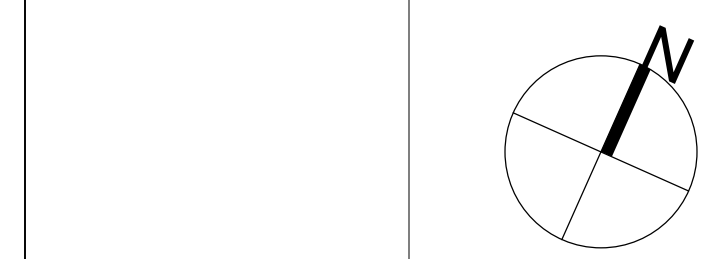

PROJECT NORTH

SCALE As indicated DATE JULY 12, 2013

JOB NUMBER 4512.001

DRAWN LD CHECKED Checker

CONSTRUCTION DOCUMENTS

A101a
EAST

DRAWING NUMBER



7/20/2013 11:41:20 AM
C:\Users\jrb\Documents\Bridgport\A101a_EAST.dwg
Shepley Bulfinch