

Shepley Bulfinch Richardson & Abbott
Architecture / Planning / Interiors / Est. 1874
2 Seaport Lane, Boston, Massachusetts 02110
T: 617.423.1700 F: 617.451.2420
www.ShepleyBulfinch.com

Spiegel Zamecnik & Shah Inc.

54 Wall Street
New Haven, CT 06511
STRUCTURAL ENGINEER

Bard, Rao + Athanas
311 Arsenal Street
Watertown, MA 02472
M.E.P. ENGINEER

Tighe & Bond
1000 Bridgeport Avenue, Floor 3
Shelton, CT 06484
CIVIL ENGINEER

Towers | Golde
85 Willow Street
New Haven, CT 06511
LANDSCAPE ARCHITECT
R.W. Sullivan


529 Main Street, Suite 203
Boston, MA 02129
CODE & REGULATORY

NOTES:

1. REFER TO A601 FOR PARTITION TYPES AND DETAILS. WALL TYPES TO BE 1A3 STUD PARTITION U.N.O.
2. PARTITION TYPES AND DIMENSIONS INCLUDED ON "a" SERIES. DETAIL INTERIOR ELEVATION KEYS, WALL PROTECTION AND NOTES INCLUDED ON "b" SERIES PLAN DRAWINGS.
3. REFER TO A912 FOR BORROWED LIGHT, DOOR AND FRAME TYPES.
4. DOORS TO BE LOCATED WITH INSIDE FACE OF JAMB 6" FROM FACE OF ADJACENT WALL U.O.N.
5. DIMENSIONS ARE TO FINISH FACE OF GWB U.N.O.
6. REFER TO INTERIOR ELEVATIONS AND TYPICAL MOUNTING HEIGHT SHEET FOR LOCATIONS OF PLUMBING FIXTURES.

- 1 HOUR FIRE SEPARATION ASSEMBLY
- 2 HOUR FIRE SEPARATION ASSEMBLY
- SMOKE BARRIER
- SMOKE PARTITION

NO.	DATE	DESCRIPTION	REVISION

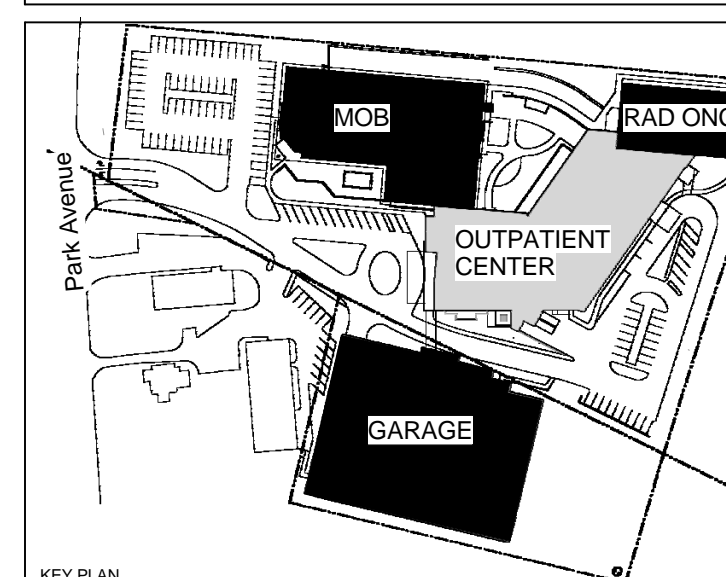

BRIDGEPORT HOSPITAL

OWNER

**PARK AVENUE CAMPUS
OUTPATIENT CENTER**
5520 Park Avenue
Trumbull, CT 06611

**LEVEL 3 PLAN - DIMS AND
PARTITION TYPES**

DRAWING TITLE

PROJECT NORTH
SCALE As indicated DATE JULY 12, 2013

JOB NUMBER 4512.001

DRAWN LD CHECKED Checker

CONSTRUCTION DOCUMENTS

**A103a
EAST**

DRAWING NUMBER

